



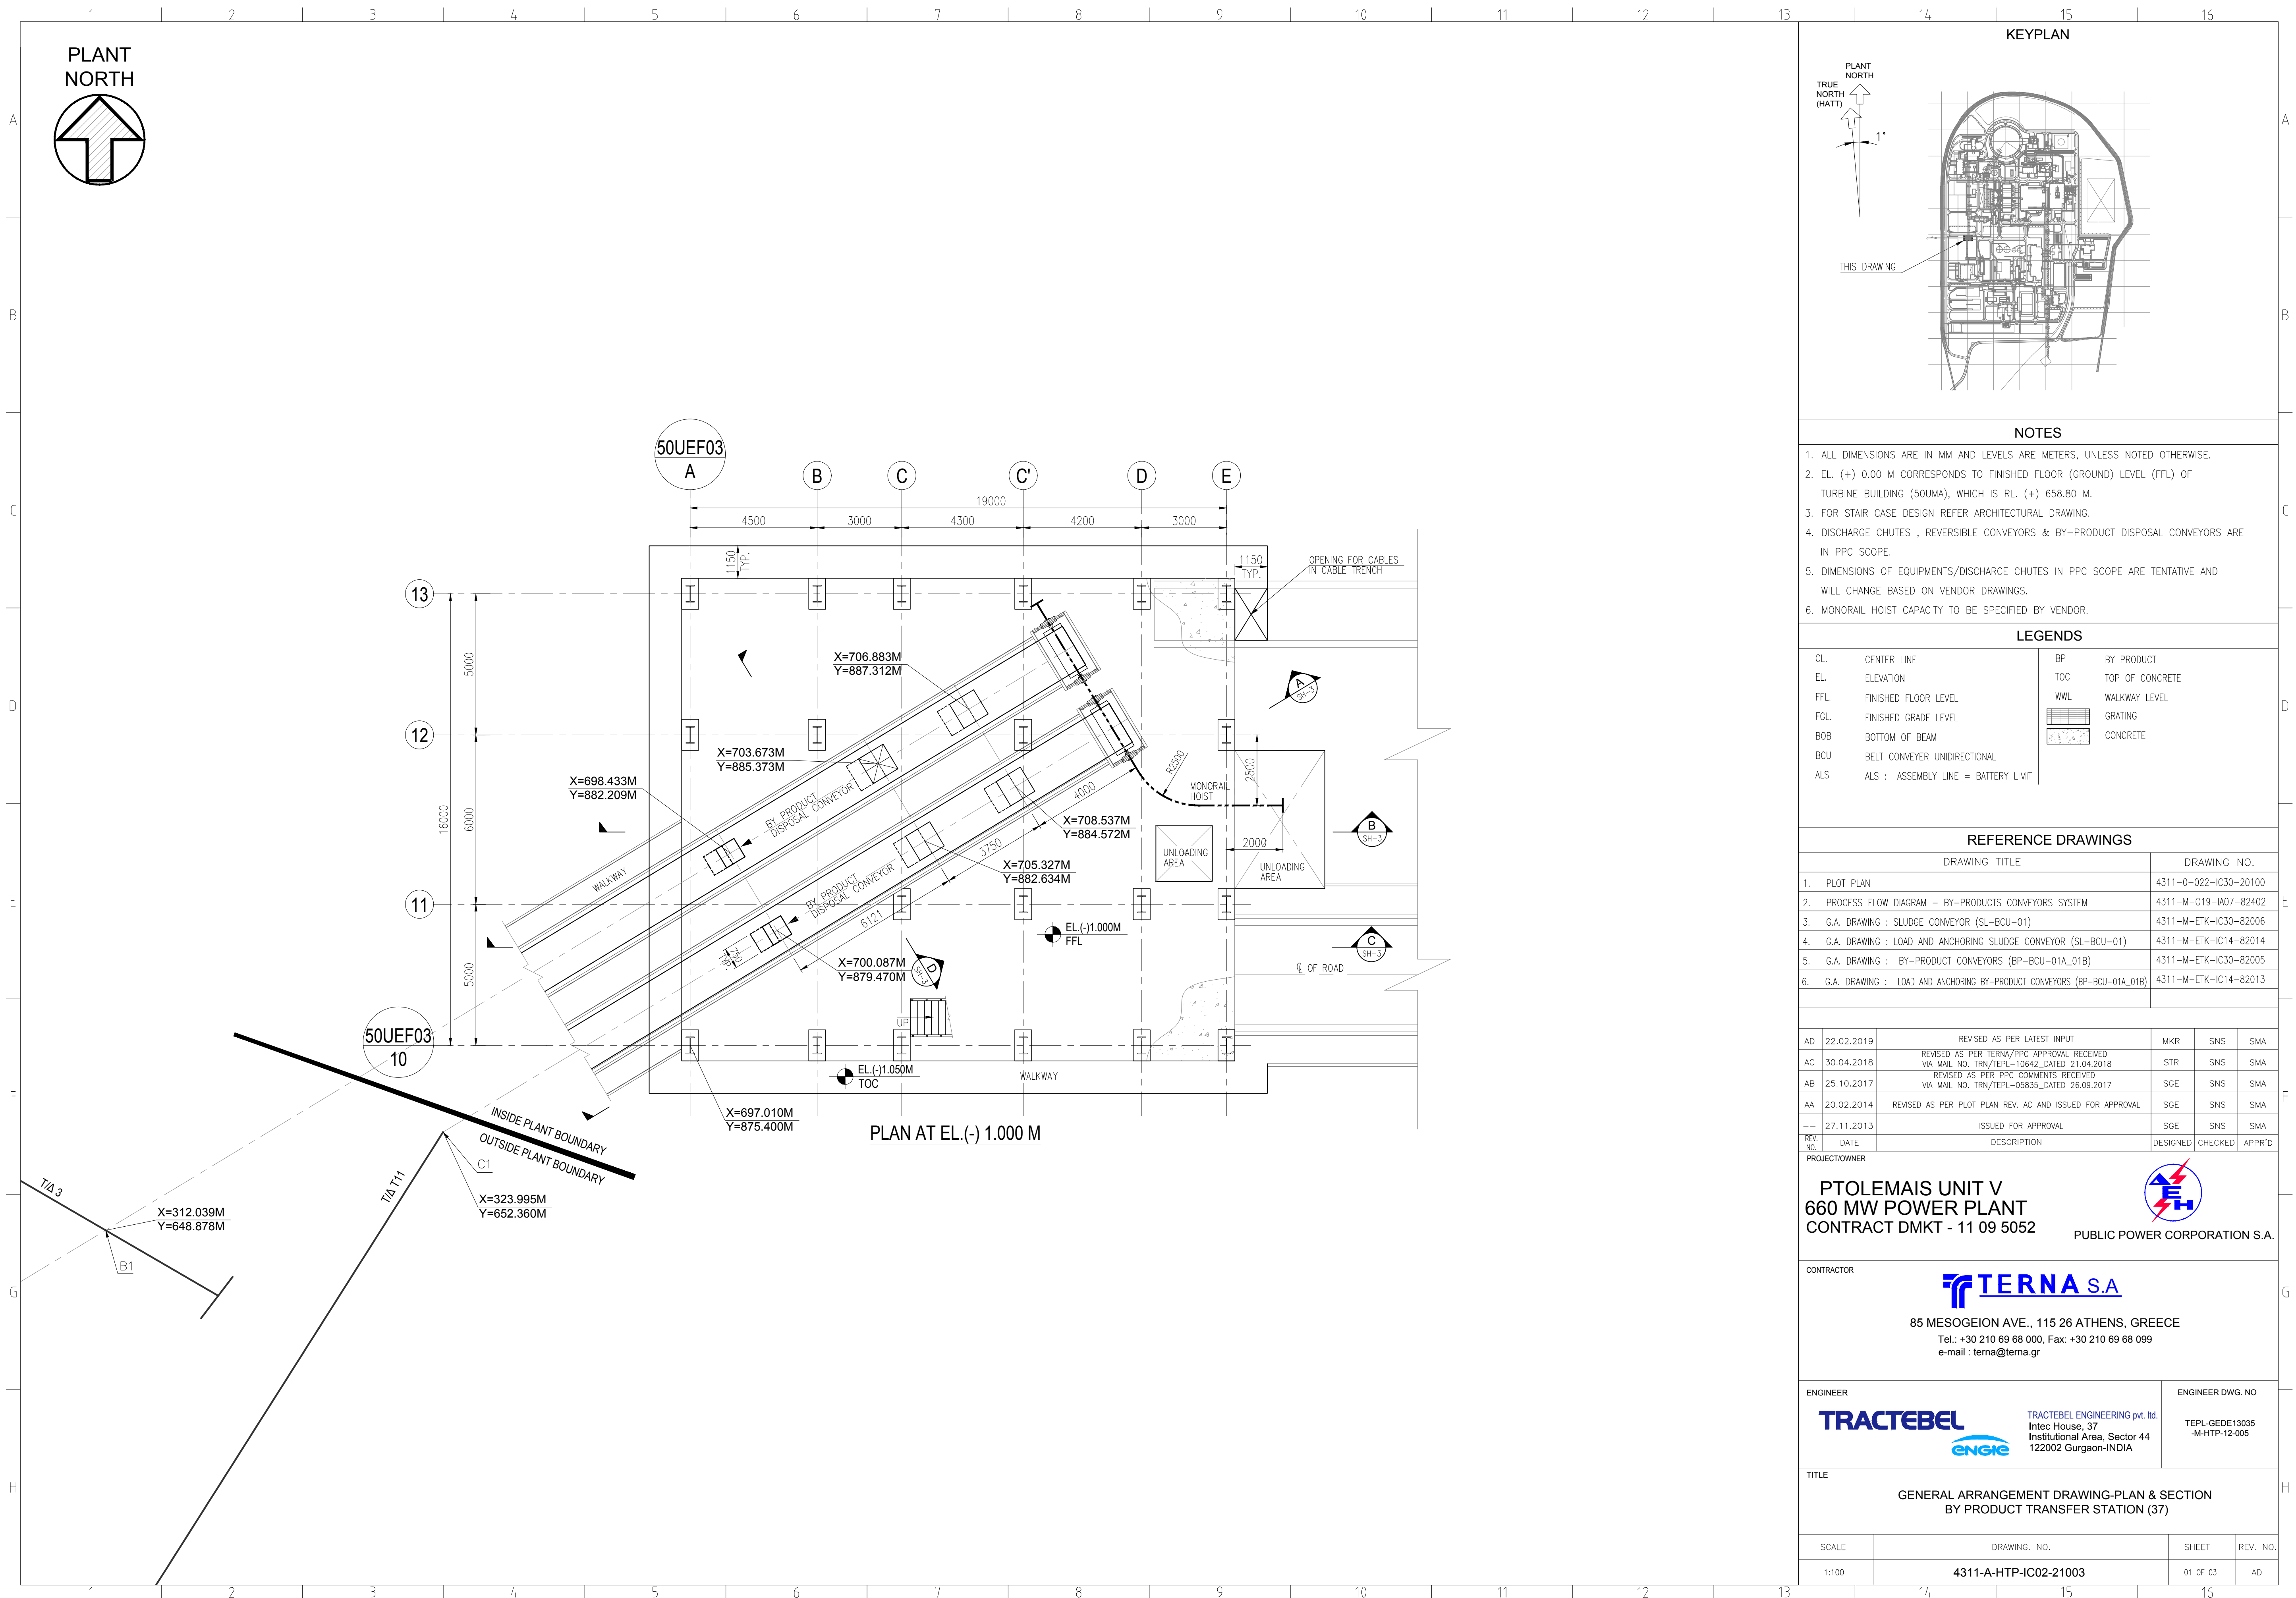

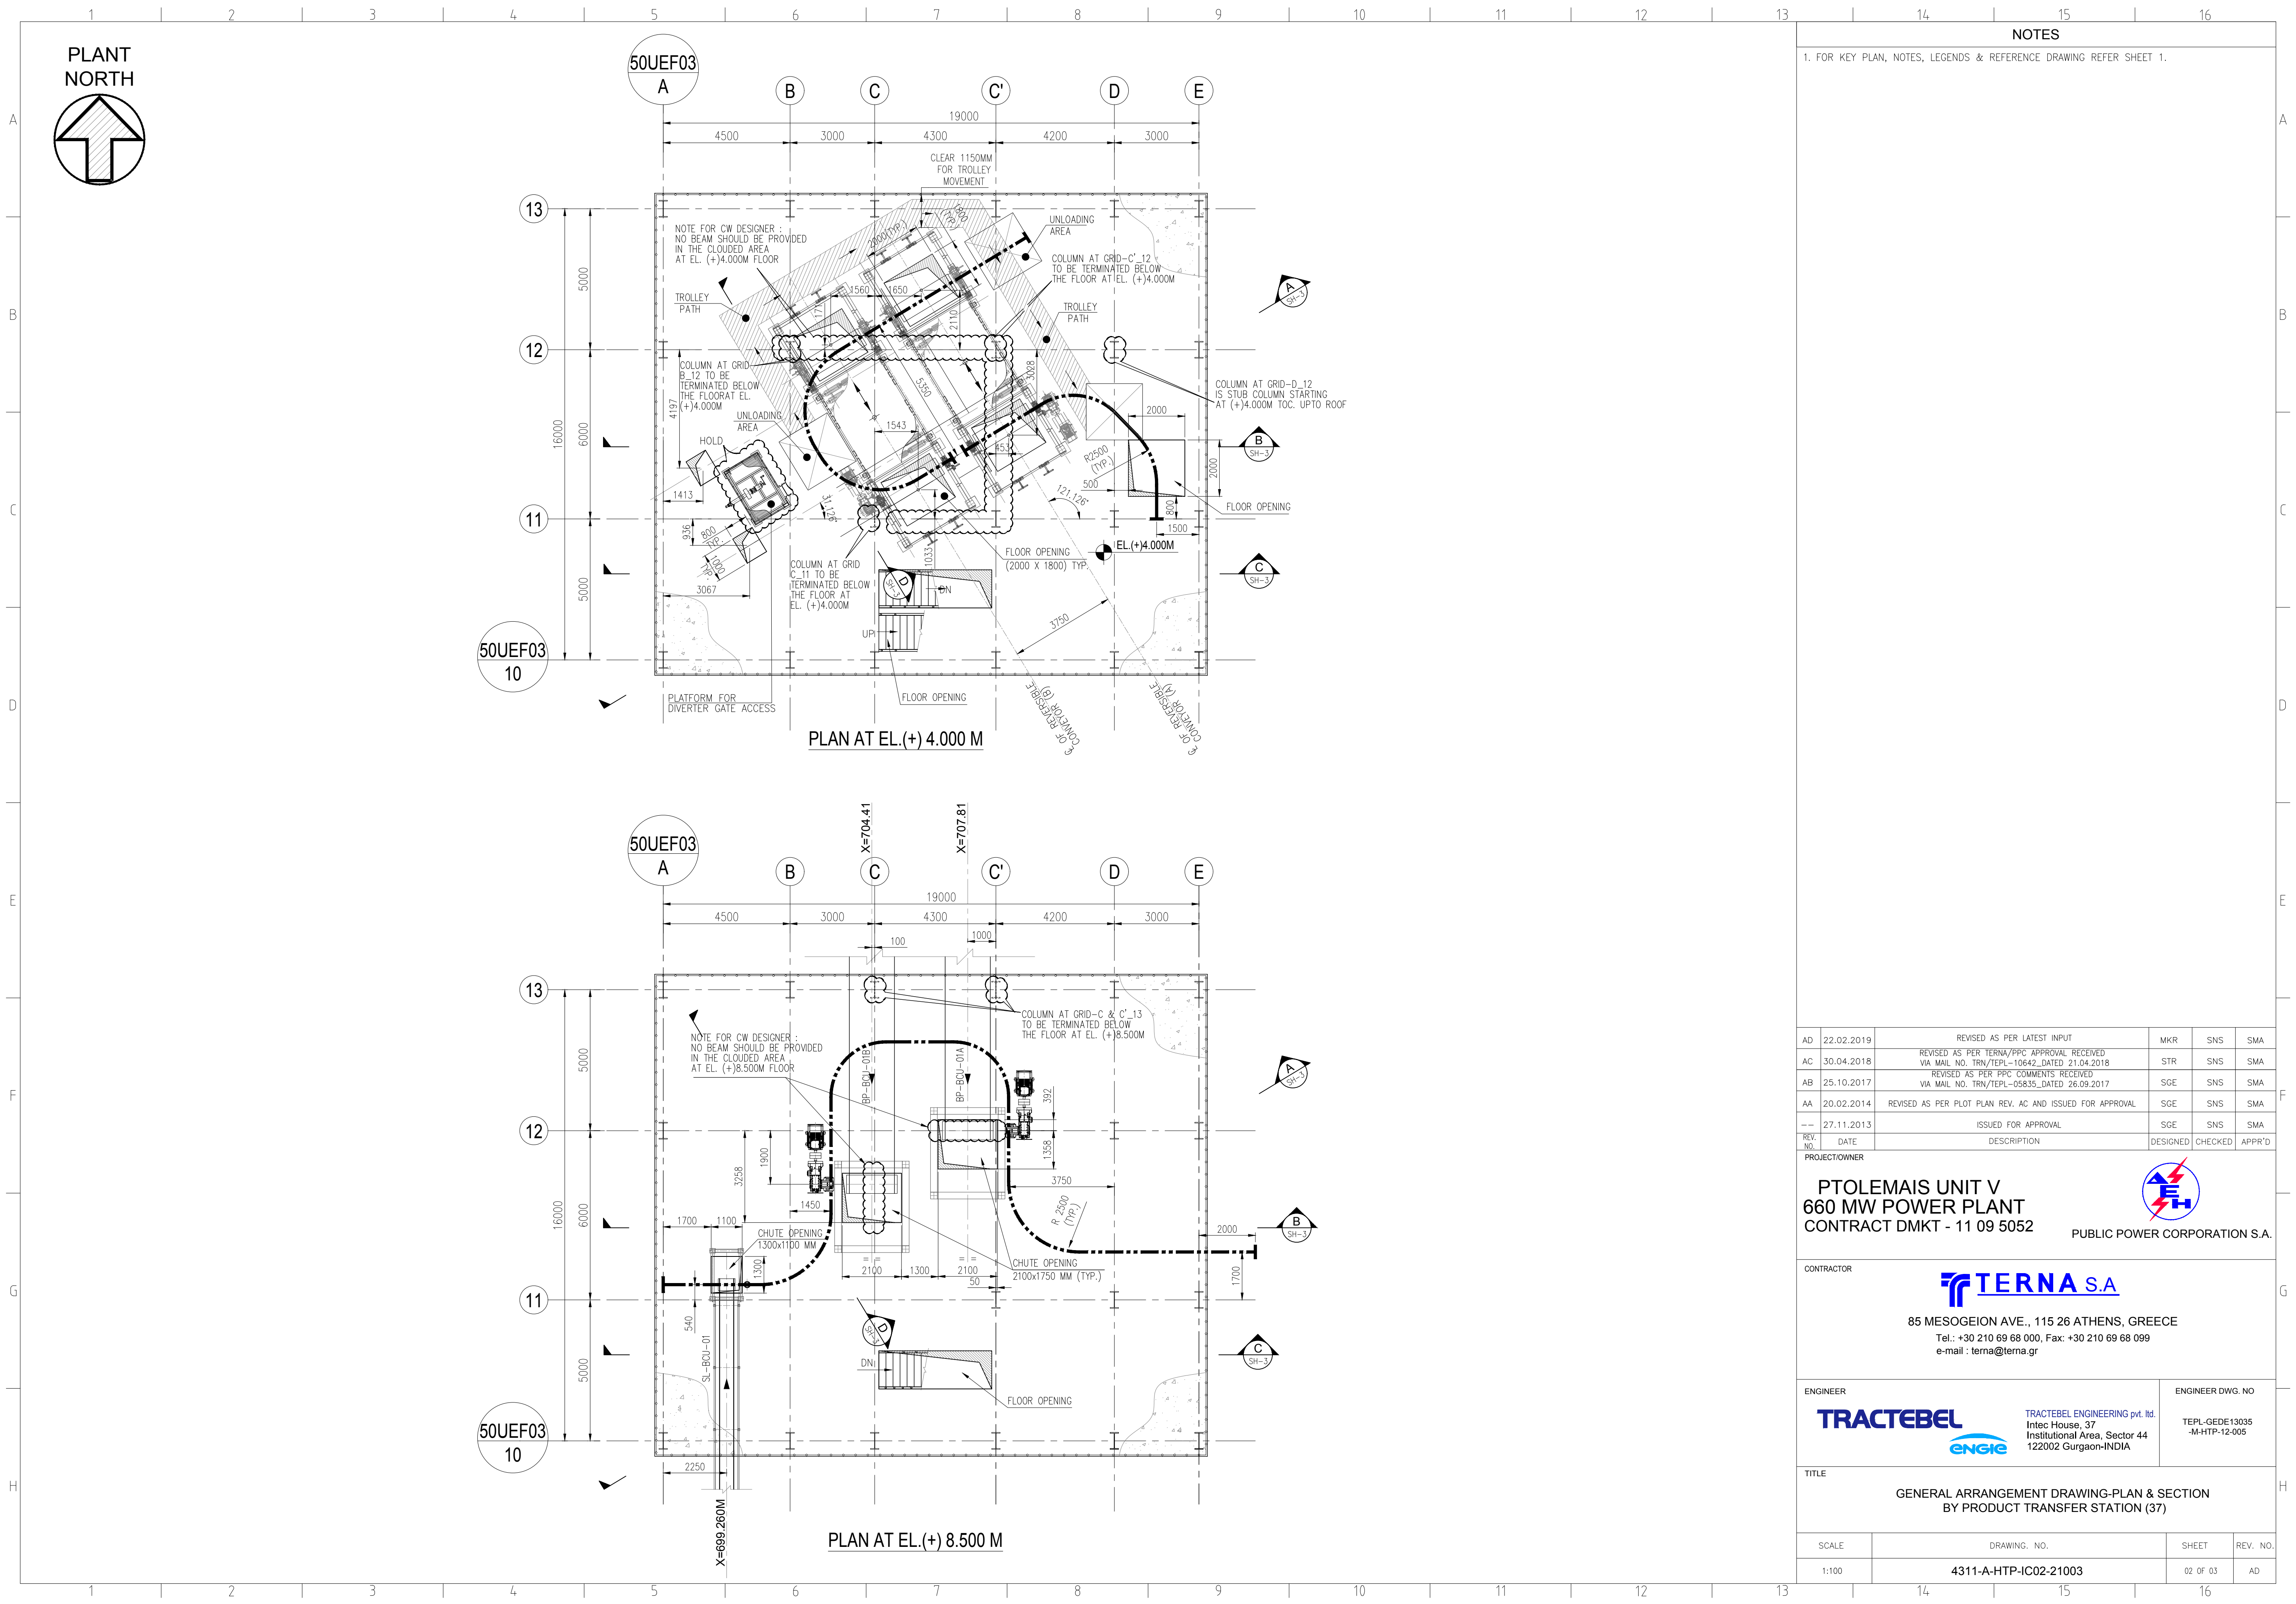


1. FOR KEY PLAN, NOTES, LEGENDS & REFERENCE DRAWING REFER SHEET 1.


AD	22.02.2019	REVISED AS PER LATEST INPUT	MKR	SNS	SMA
AC	30.04.2018	REVISED AS PER TERNA/PPC APPROVAL RECEIVED VIA MAIL NO. TRN/TEPI-10642-DATED 21.04.2018	STR	SNS	SMA
AB	25.10.2017	REVISED AS PER PPC COMMENTS RECEIVED VIA MAIL NO. TRN/TEPI-0583-DATED 26.09.2017	SGE	SNS	SMA
AA	20.02.2014	REVISED AS PER PLOT PLAN REV. AC AND ISSUED FOR APPROVAL	SGE	SNS	SMA
--	27.11.2013	ISSUED FOR APPROVAL	SGE	SNS	SMA
REV. NO.	DATE	DESCRIPTION	DESIGNED	CHECKED	APPR'D

NO.	
PROJECT/OWNER	

 
PTOLEMAIS UNIT V
660 MW POWER PLANT
CONTRACT DMKT - 11 09 5052



CONTRACTOR	
------------	--

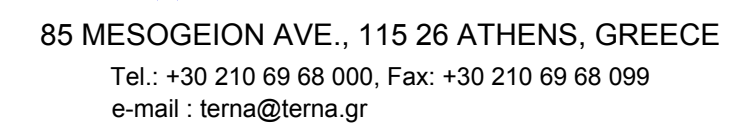

ENGINEER

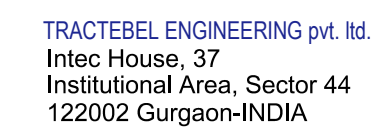


ENGINEER DWG. NO

TEPL-GEDE13035
-M-HTP-12-005

	TITLE
--	-------

GENERAL ARRANGEMENT DRAWING-PLAN & SECTION
BY PRODUCT TRANSFER STATION (37)

SCALE	DRAWING. NO.	SHEET	REV. NO.
1:100	4311-A-HTP-IC02-21003	02 OF 03	AD

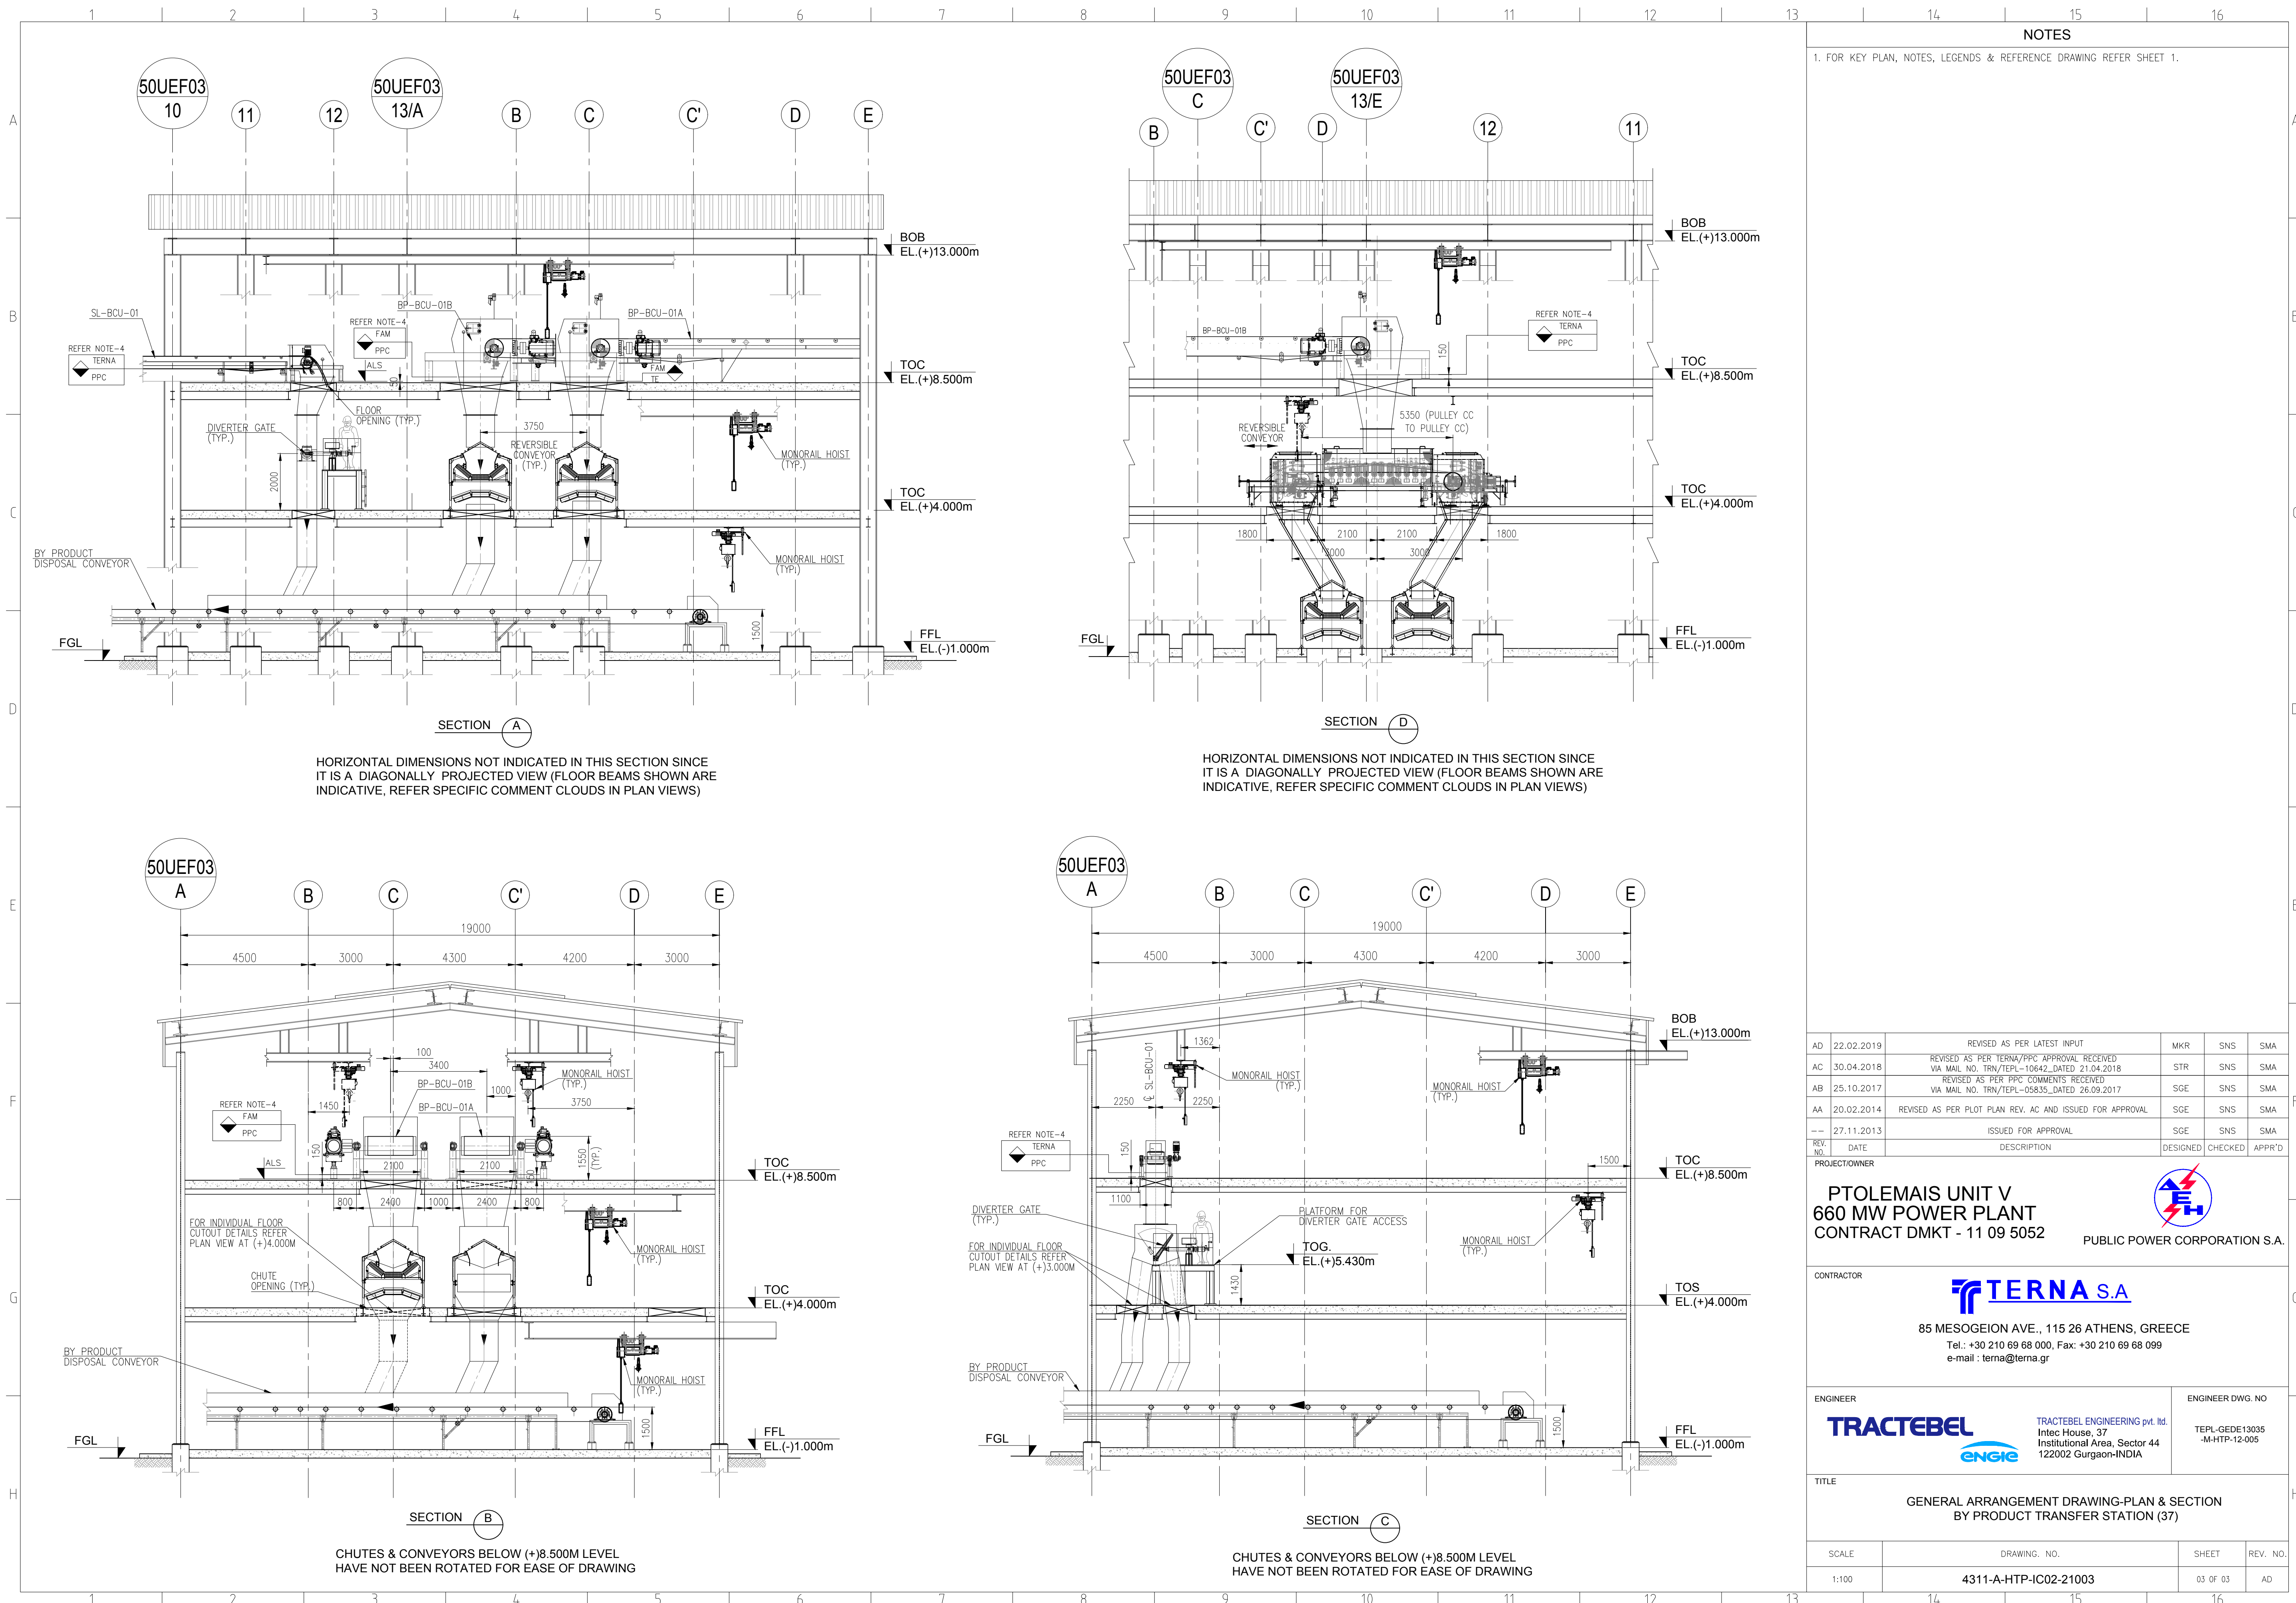


NOTES

1. FOR KEY PLAN, NOTES, LEGENDS & REFERENCE DRAWING REFER SHEET 1.

AD	22.02.2019	REVISED AS PER LATEST INPUT	MKR	SNS	SMA
AC	30.04.2018	REVISED AS PER TERNA/PPC APPROVAL RECEIVED VIA MAIL NO. TRN/TEPL-10642_DATED 21.04.2018	STR	SNS	SMA
AB	25.10.2017	REVISED AS PER PPC COMMENTS RECEIVED VIA MAIL NO. TRN/TEPL-05635_DATED 26.09.2017	SGE	SNS	SMA
AA	20.02.2014	REVISED AS PER PLOT PLAN REV. AC AND ISSUED FOR APPROVAL	SGE	SNS	SMA
--	27.11.2013	ISSUED FOR APPROVAL	SGE	SNS	SMA
REV. NO.	DATE	DESCRIPTION	DESIGNED	CHECKED	APPR'D

PROJECT/OWNER

PTOLEMAIS UNIT V
660 MW POWER PLANT
CONTRACT DMKT - 11 09 5052

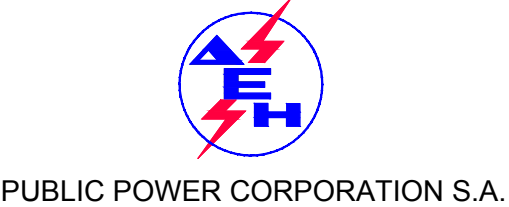

CONTRACTOR



85 MESOGEION AVE., 115 26 ATHENS, GREECE
Tel.: +30 210 69 68 000, Fax: +30 210 69 68 099
e-mail : terna@terna.gr

ENGINEER



TRACTEBEL ENGINEERING pvt. ltd.
Intec House, 37
Institutional Area, Sector 44
122002 Gurgaon-INDIA

ENGINEER DWG. NO.



TEPL-GEDE13035
-M-HTP-12-005

TITLE

GENERAL ARRANGEMENT DRAWING-PLAN & SECTION
BY PRODUCT TRANSFER STATION (37)

SCALE	DRAWING. NO.	SHEET	REV. NO.
1:100	4311-A-HTP-IC02-21003	03 OF 03	AD